



MINNESOTA STATE MAP

1

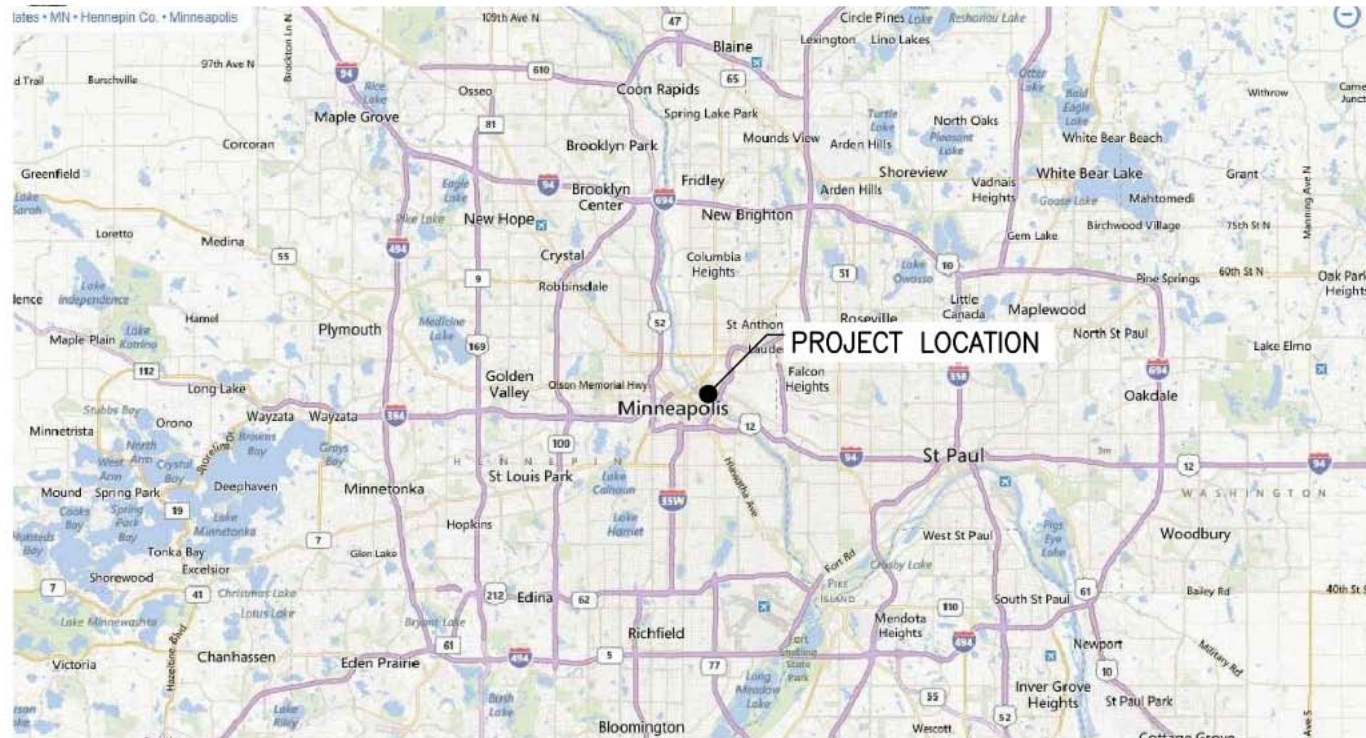


ENLARGED SITE MAP

2

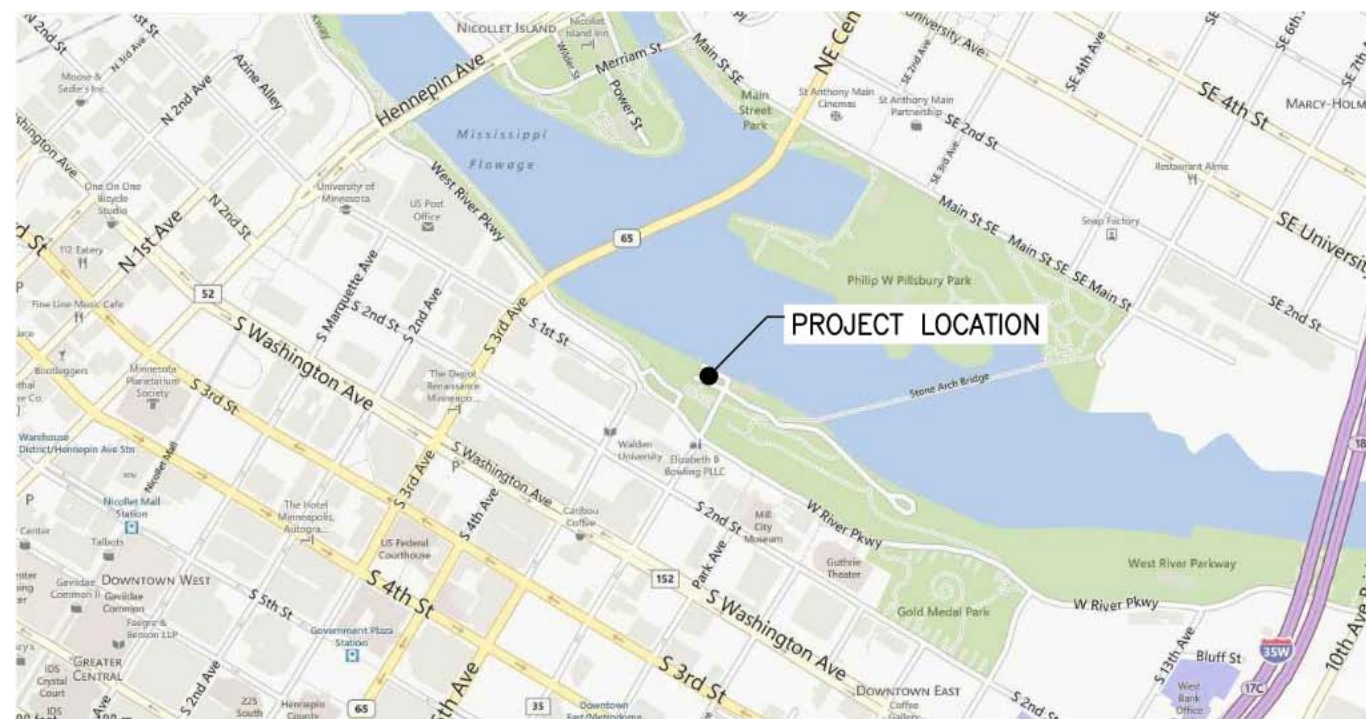

DETAILED SITE MAP

 3



1	ISSUED FOR REVIEW	JVB	JT	06/28/13			
REV	REVISION DESCRIPTION	DWN	APP	REV DATE			

SEAL	

CONSULTANT

1299 EAGAN INDUSTRIAL RD, SUITE 201
EAGAN, MINNESOTA 55121
© 651-208-0108 ~ F 651-209-0109

CONSULTANT



1800 PIONEER CREEK CENTER
MAPLE PLAIN, MINNESOTA 55359
763-473-4200
763-479-4242

PROJECT TITLE

CONCEPT PLAN

CROWN HYDRO, LLC

PROJECT VICINITY MAP			
DWN BY	CHK'D	APP'D	DWG DATE
JVB	JT	JT	06/28/2013
PROJECT NO.	SHEET NO.	SCALE	
2636-02	FIGURE 1	AS NOTED	
		REV NO.	
		1	

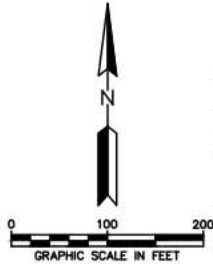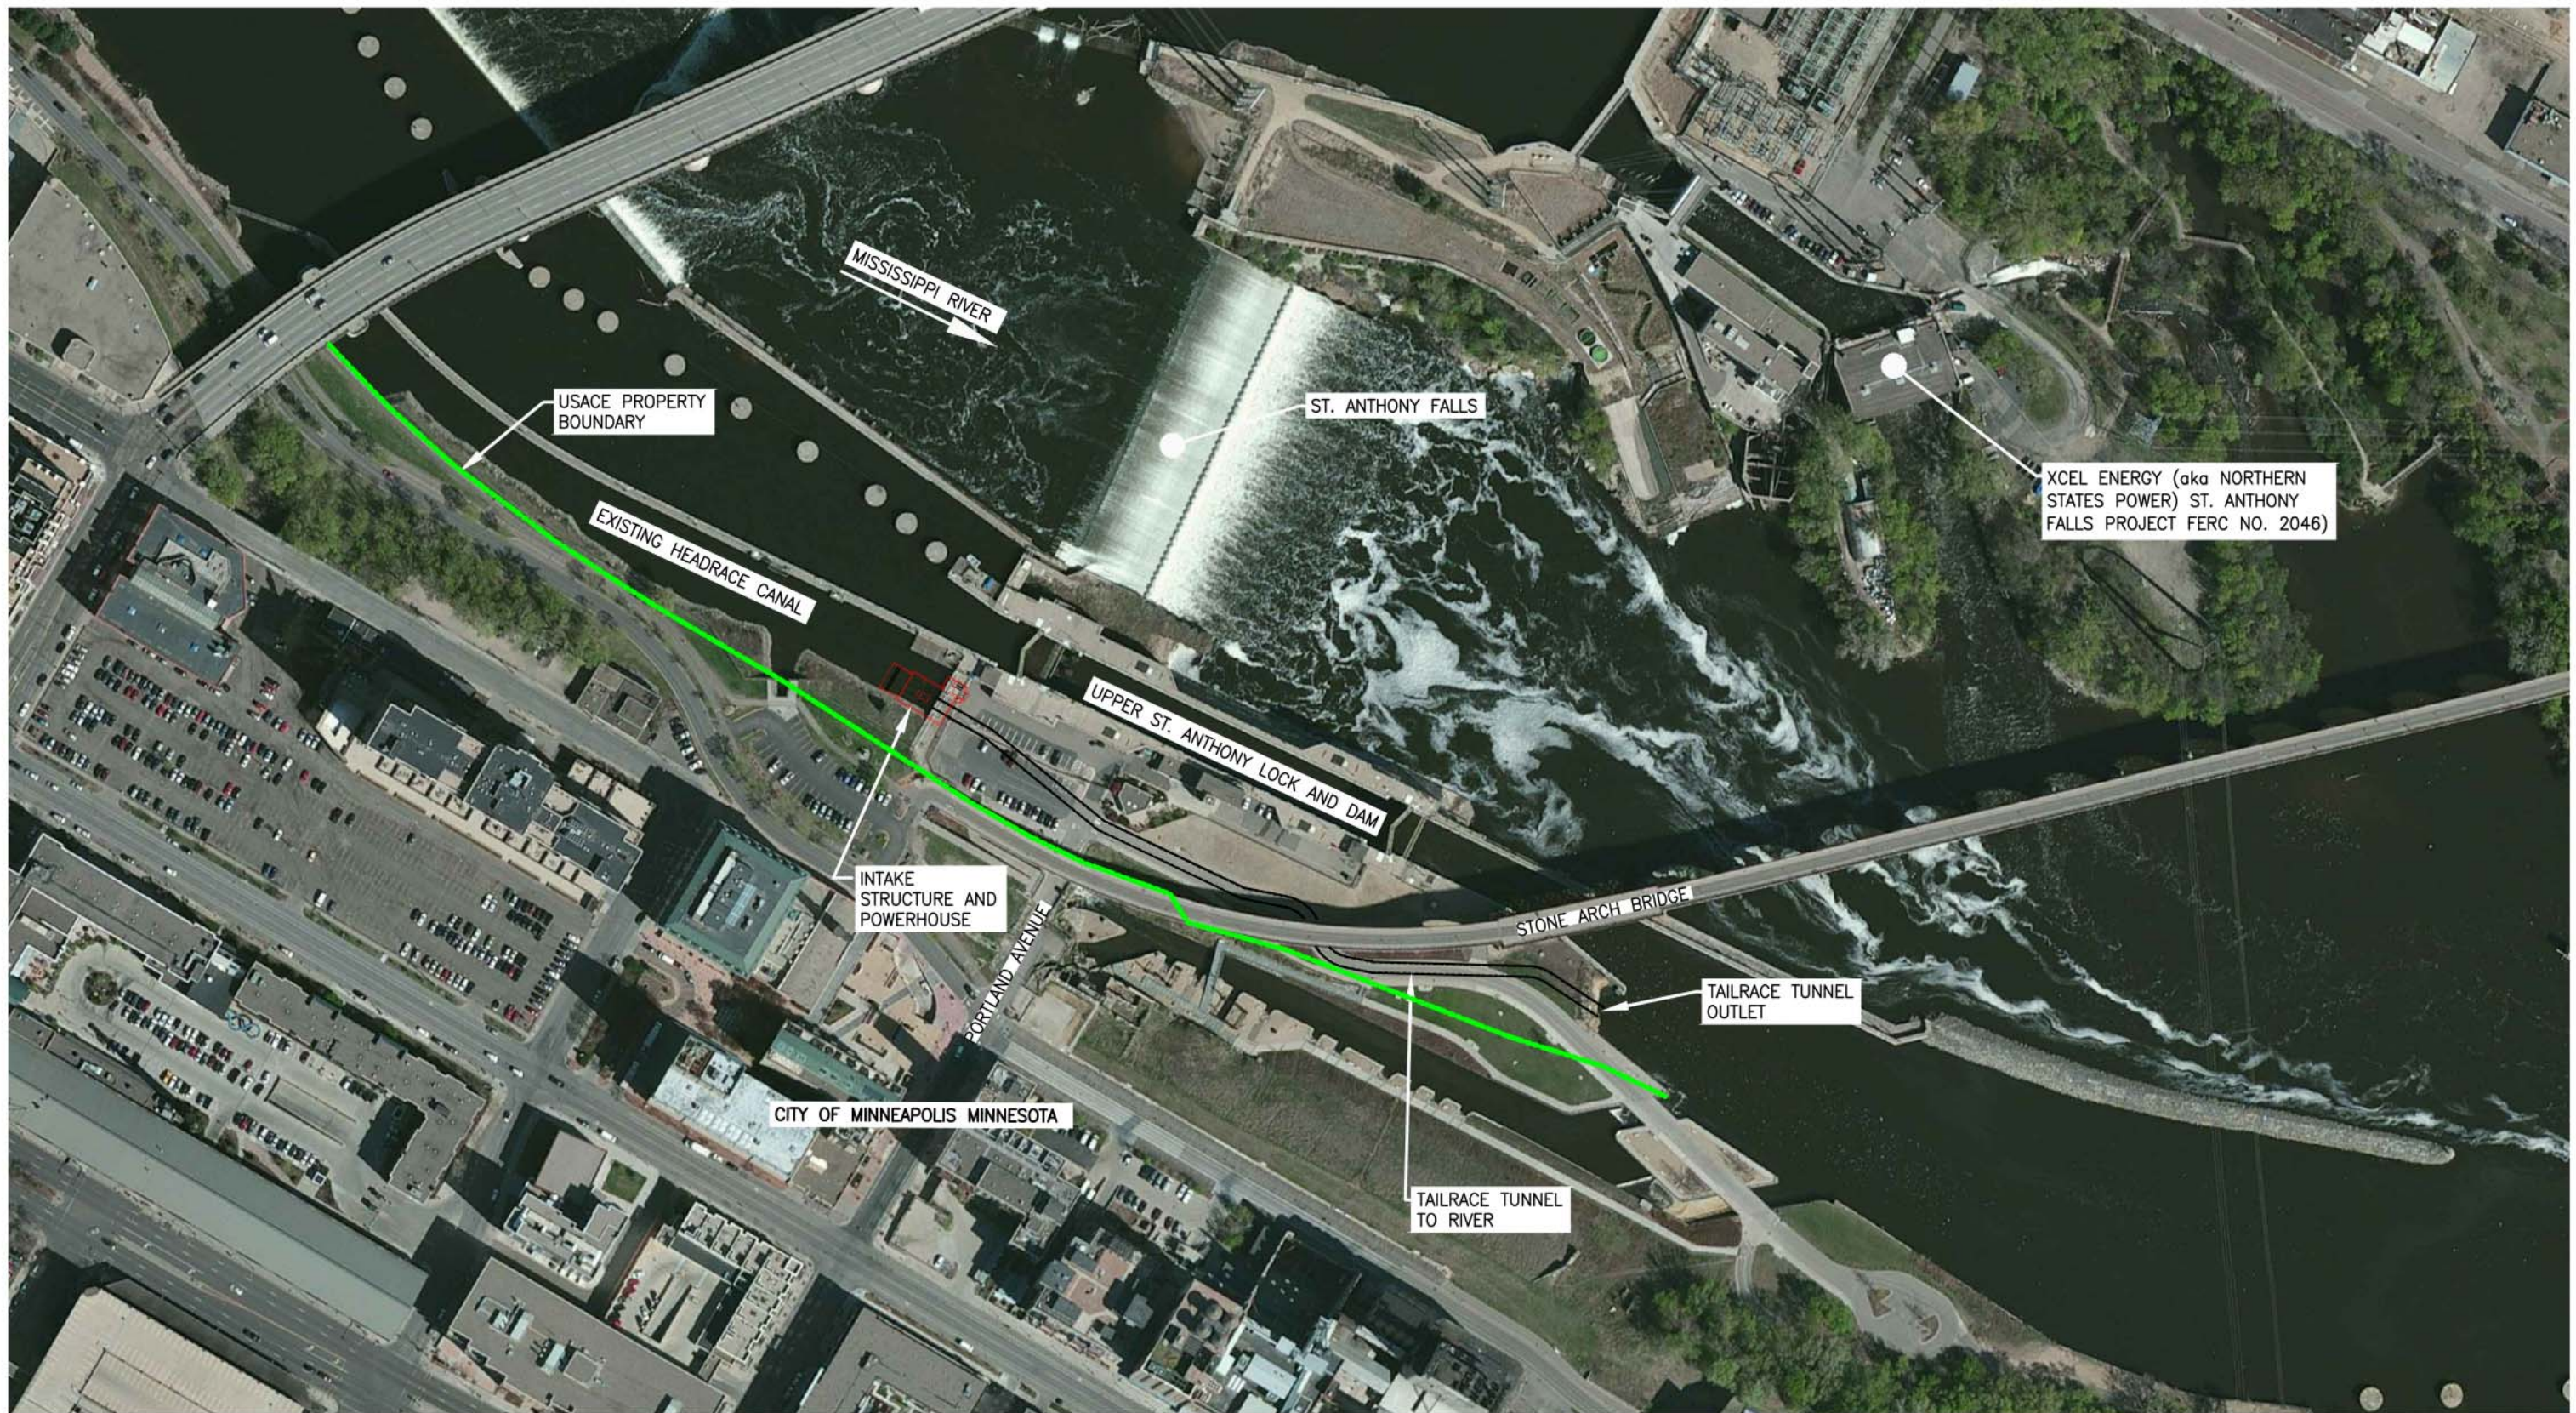

REV	REVISION DESCRIPTION	DWN	APP	REV DATE
1	ISSUED FOR REVIEW	JVB	JT	06/28/13

SEAL	
------	--

CONSULTANT




1299 EAGAN INDUSTRIAL RD. SUITE 201
EAGAN, MINNESOTA 55121
P 651-209-0108 F 651-209-0109

CONSULTANT

1800 PIONEER CREEK CENTER
MAPLE PLAIN, MINNESOTA 55359
763-473-4200
763-479-4242

PROJECT TITLE	CONCEPT PLAN
	CROWN HYDRO, LLC

SHEET TITLE				PROJECT LOCATION MAP			
DWN BY	CHK'D	APP'D	DWG DATE	SCALE	REV NO.		
JVB	JT	JT	06/28/2013	AS NOTED			
PROJECT NO.			SHEET NO.		REV NO.		
2636-02			FIGURE 2		1		

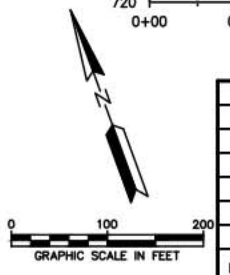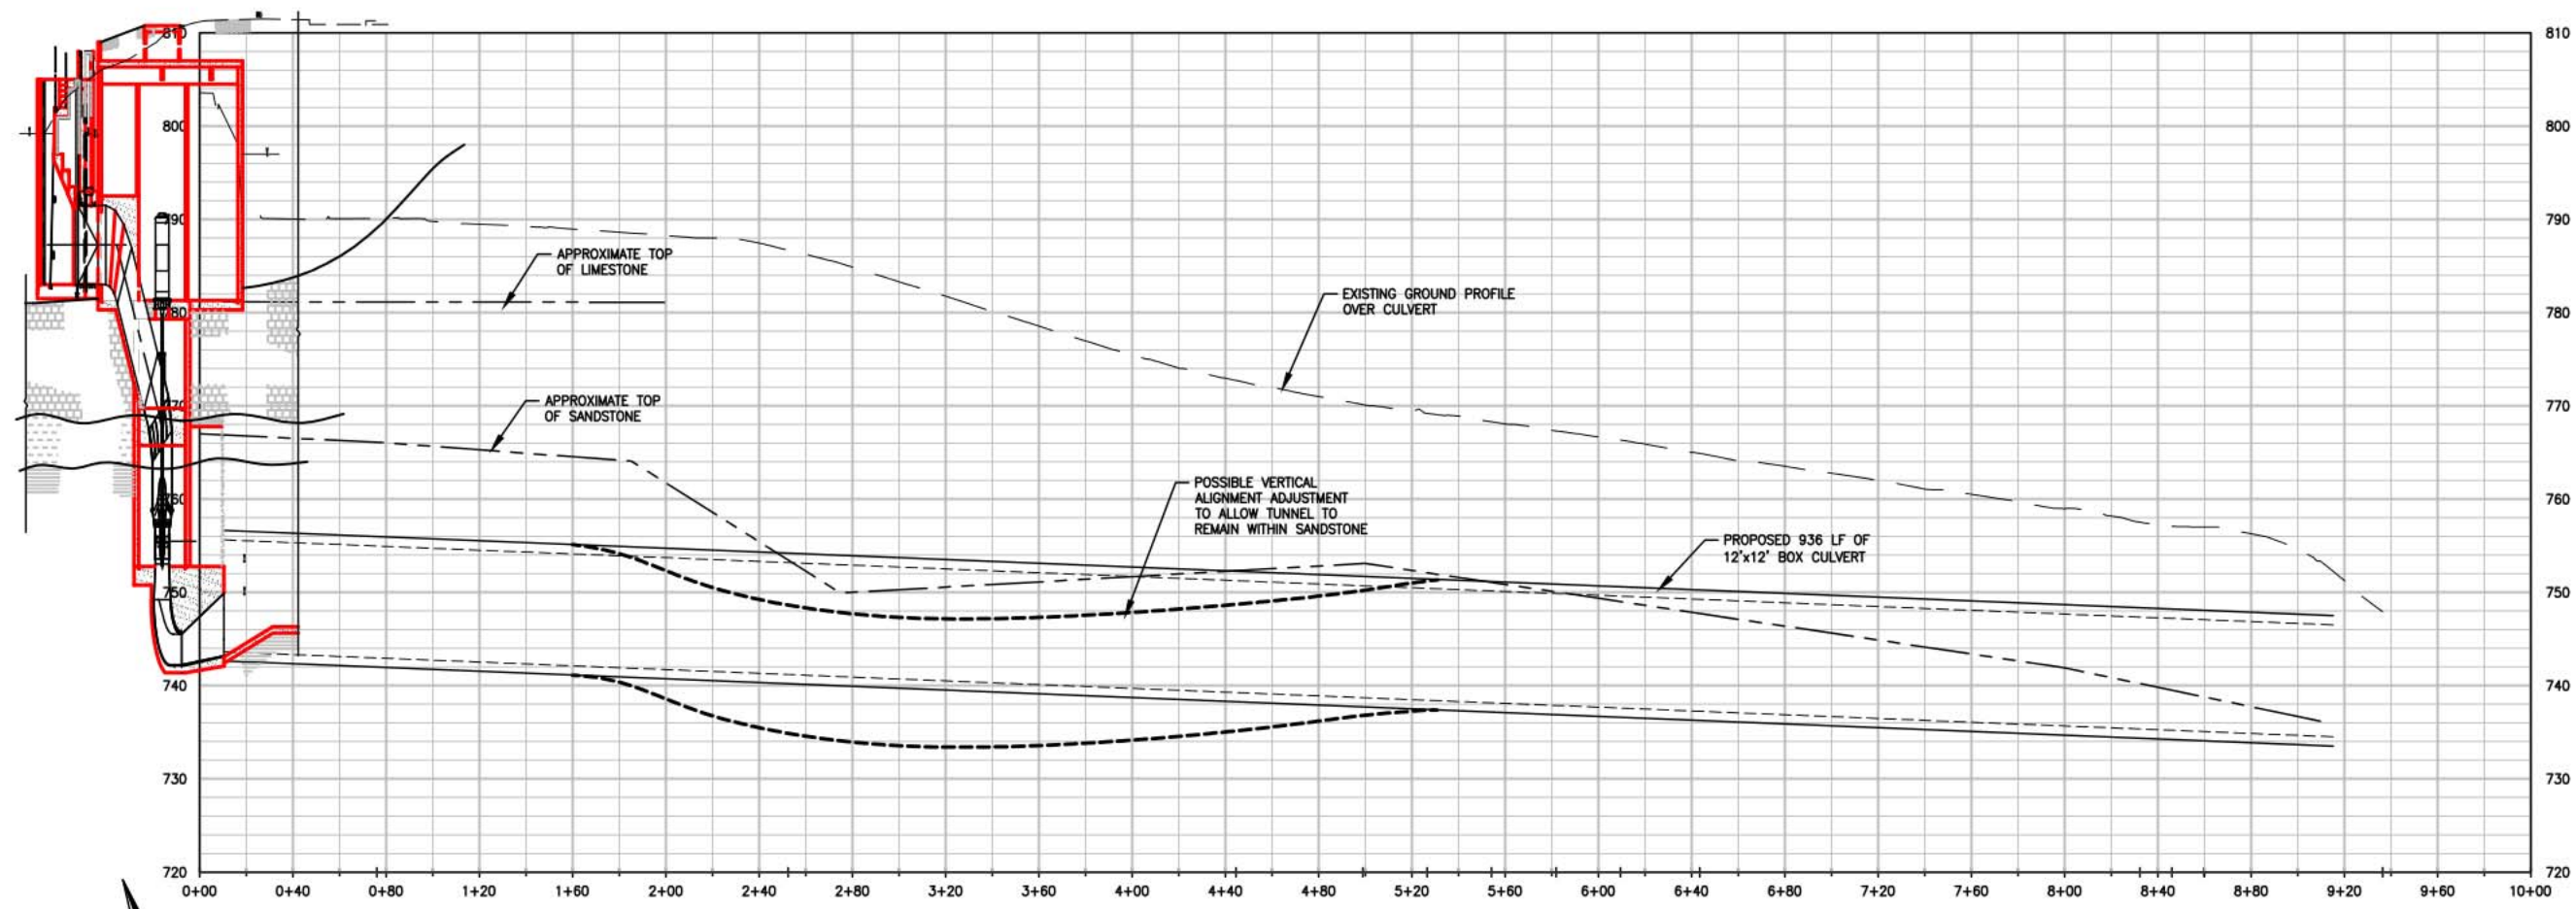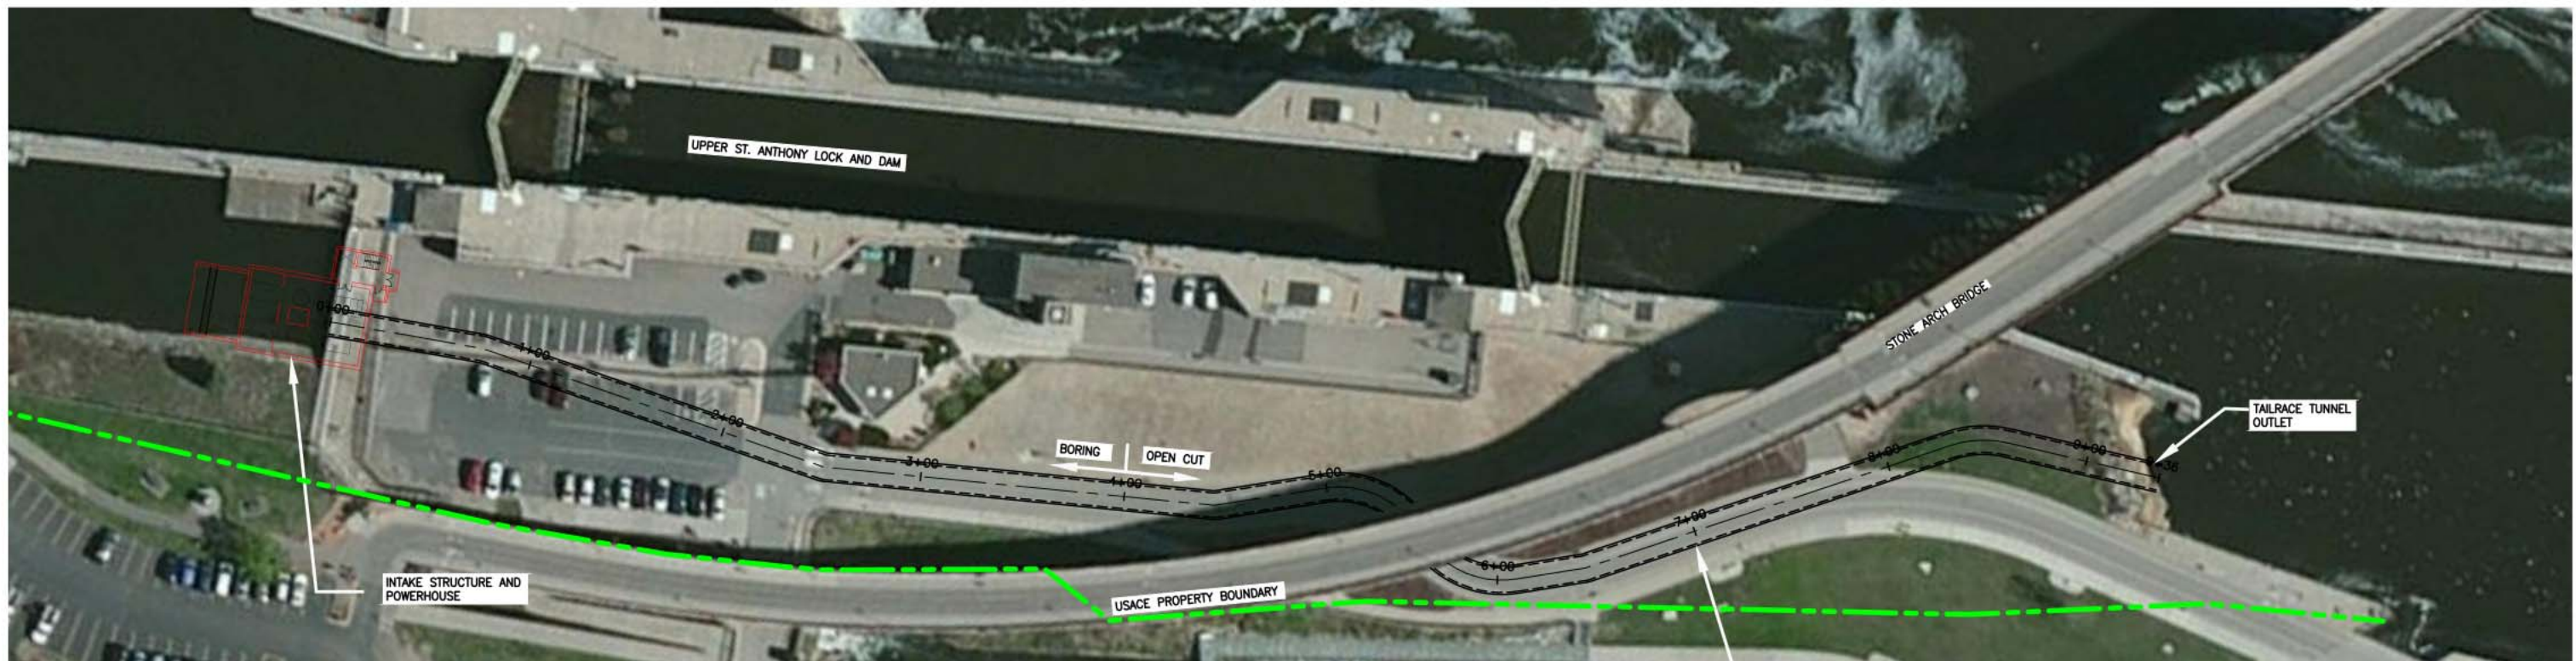

REV	REVISION DESCRIPTION	DWN	APP	REV DATE
1	ISSUED FOR REVIEW	JVB	JT	06/28/13

SEAL					

CONSULTANT

1299 EGAN INDUSTRIAL RD. SUITE 201
 EAGAN, MINNESOTA 55121
 P: 651-209-0100 F: 651-209-0109



CONSULTANT

1800 PIONEER CREEK CENTER
 MAPLE PLAIN, MINNESOTA 55359
 763-473-4200
 763-479-4242

PROJECT TITLE: CONCEPT PLAN

CROWN HYDRO, LLC

SHEET TITLE: PLAN AND PROFILE			
DWN BY: JVB	CHK'D BY: JT	APP'D BY: JT	DWG DATE: 06/28/2013
PROJECT NO.: 2636-02		SCALE: AS NOTED	
SHEET NO.: FIGURE 3		REV NO.: 1	

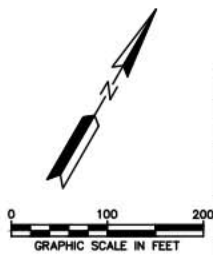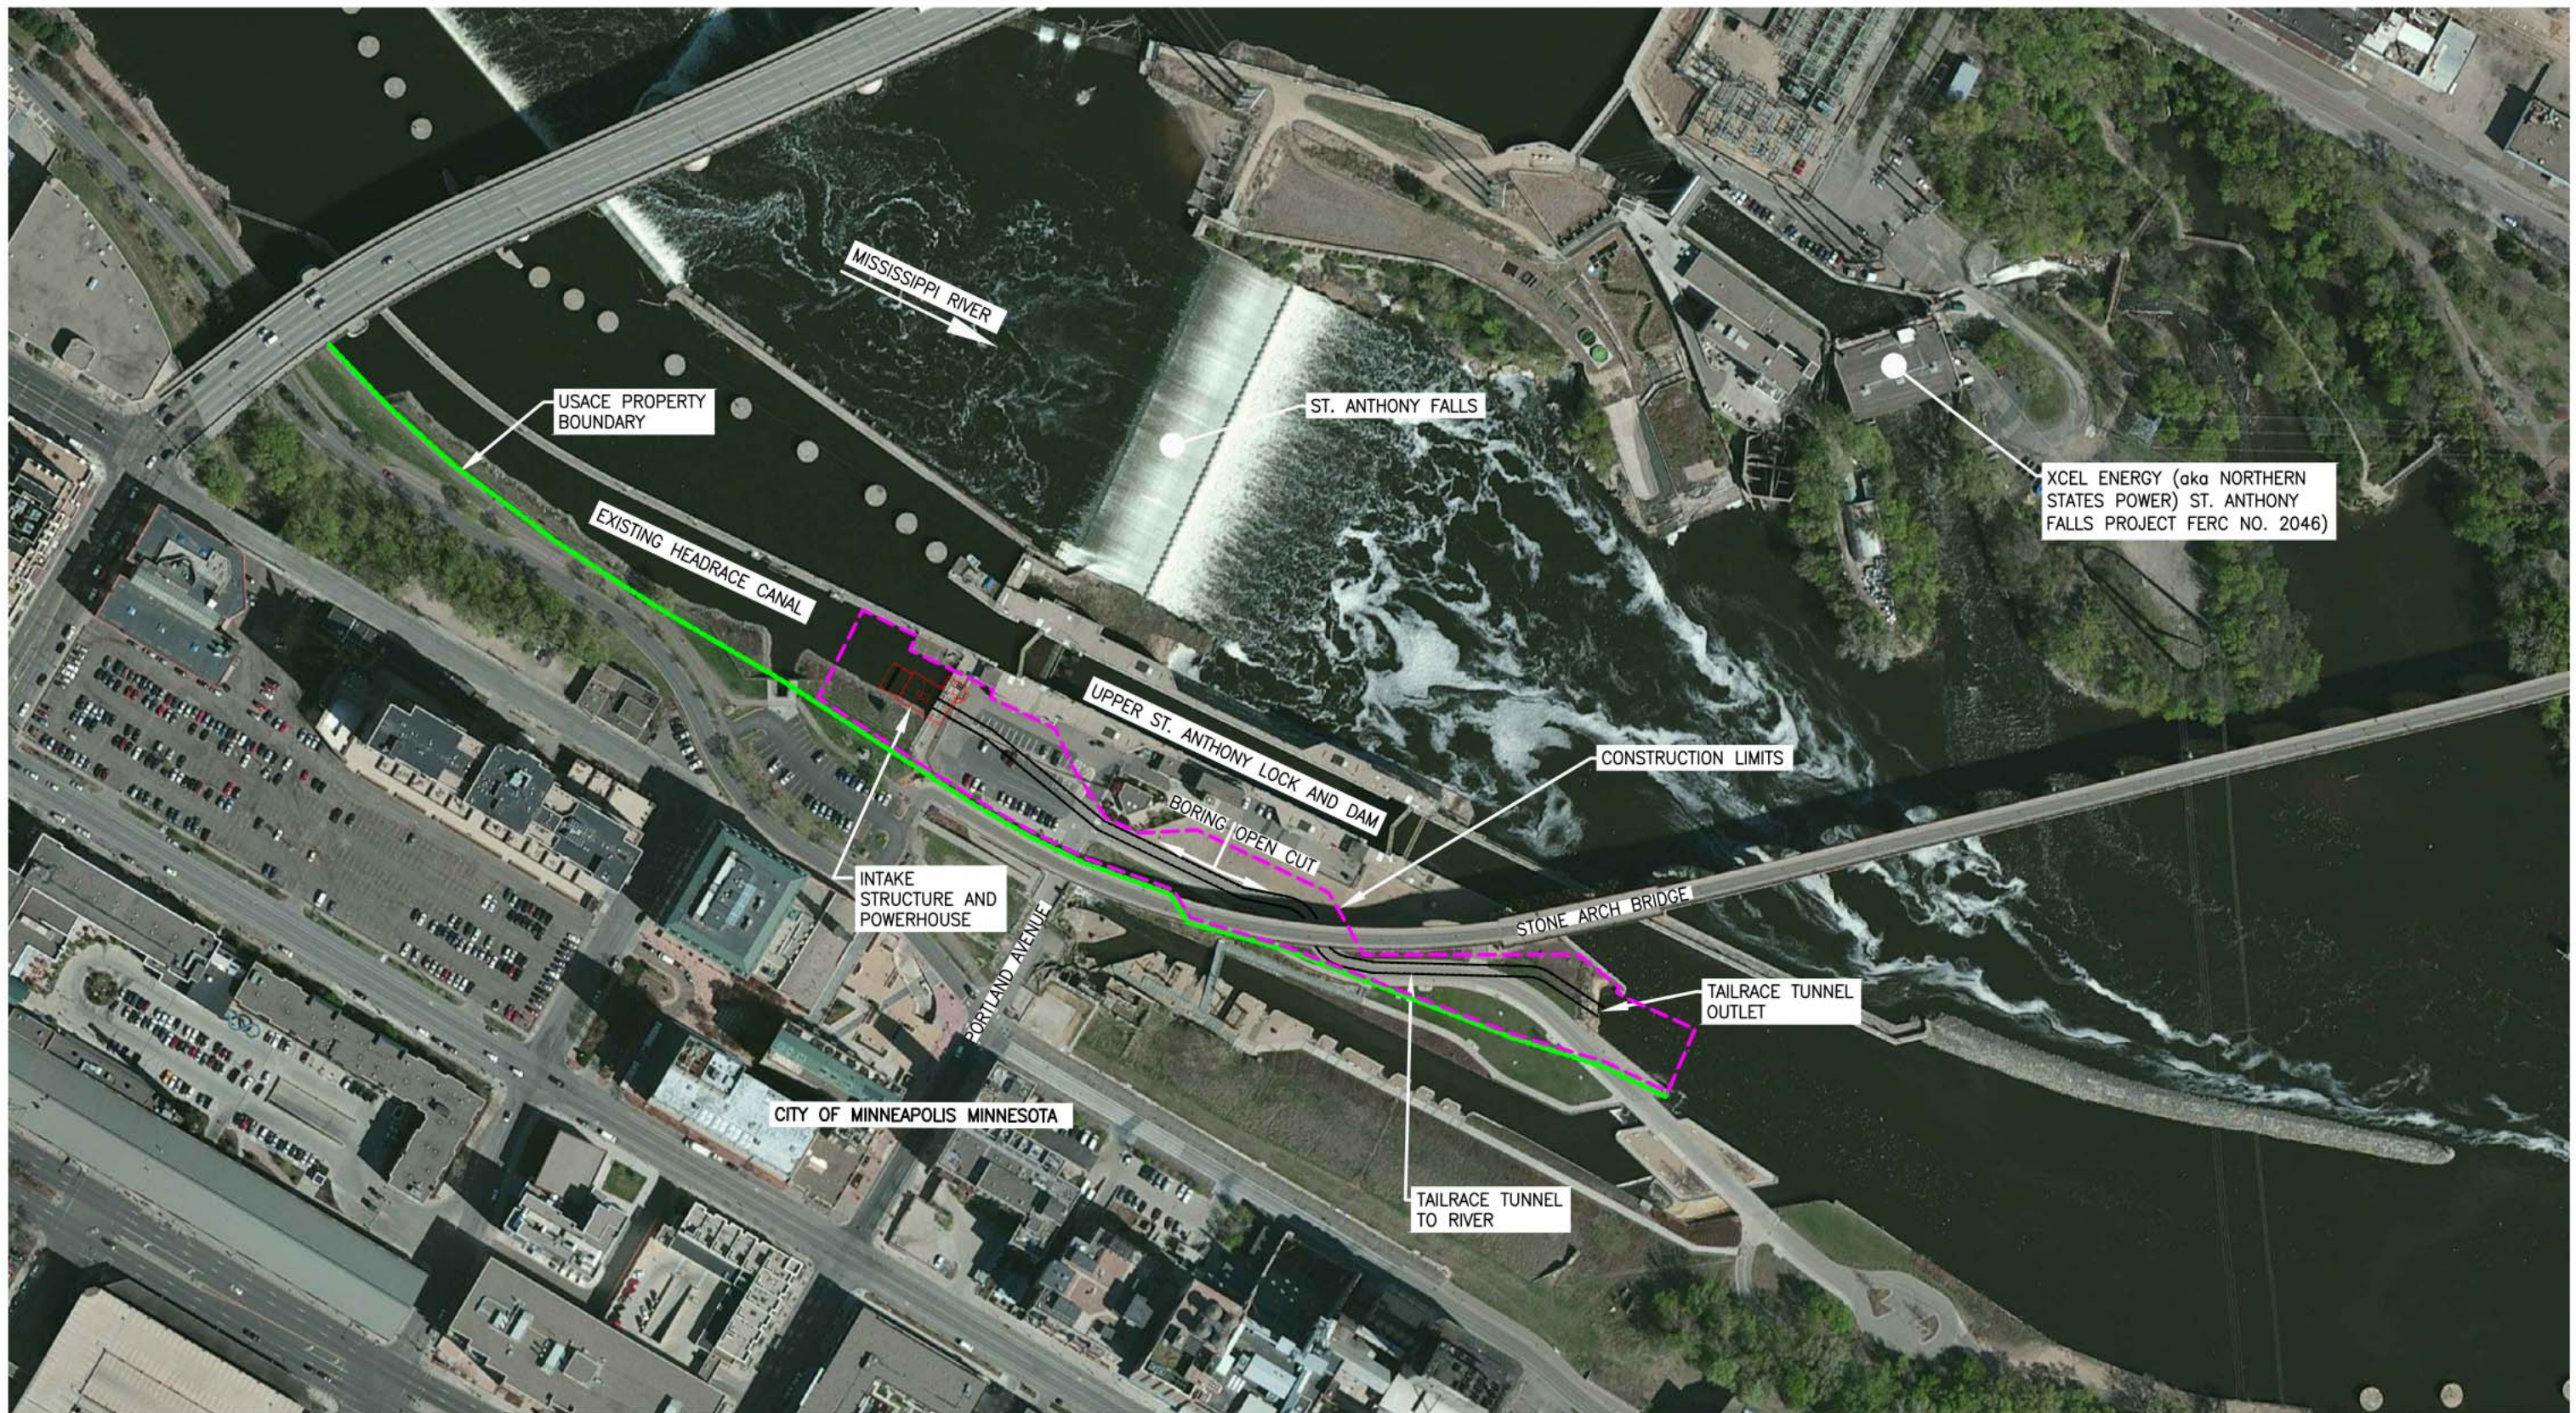

REV	REVISION DESCRIPTION	DWN	APP	REV DATE
1	ISSUED FOR REVIEW	JVB	JT	06/28/13

SEAL	
------	--

CONSULTANT

1299 EAGAN INDUSTRIAL RD. SUITE 201
EAGAN, MINNESOTA 55121
P 651-209-0108 F 651-209-0109

CONSULTANT

1800 PIONEER CREEK CENTER
MAPLE PLAIN, MINNESOTA 55359
763-473-4200
763-479-4242

PROJECT TITLE	CONCEPT PLAN
	CROWN HYDRO, LLC

SHEET TITLE				PROPOSED CONSTRUCTION LIMITS
DWN BY	CHK'D	APP'D	DWG DATE	06/28/2013
JVB	JT	JT	SCALE	AS NOTED
PROJECT NO.	SHEET NO.		REV NO.	
2636-02	FIGURE 4		1	



TAIL RACE OUTLET

1	ISSUED FOR REVIEW	JVB	JT	06/28/13
REV	REVISION DESCRIPTION	DWN	APP	REV DATE

SEAL

CONSULTANT

ENGINEERING PARTNERS
INTERNATIONAL LLC
1299 EAGAN INDUSTRIAL RD, SUITE 201
EAGAN, MINNESOTA 55121
0 651-209-0100 • F 651-209-0109

CONSULTANT

Wenck
Wenck Associates, Inc.
Consulting Engineers
1800 PIONEER CREEK CENTER
MAPLE PLAN, MINNESOTA 55359
763-473-4200
763-479-4242
Web Site: www.wenck.com

PROJECT TITLE	CONCEPT PLAN
CROWN HYDRO , LLC	

SHEET TITLE		TAIL RACE OUTLET		
DWN BY	CHK'D	APP'D	DWG DATE	06/28/2013
JVB	JT	JT	SCALE	AS NOTED
PROJECT NO.	SHEET NO.	REV NO.		
2636-02	FIGURE 6	1		